

CONSULTANT

Structural

Sanitary

Electrical

Client

**AHISEA CONSTRUCTION
COMMITE**

Revisions

Revised by	Description	Date

Project Location

AHISEA , TIGRAY

Project No. _____

Design by _____

CAD by _____

Checked by _____

Date _____

Scale

SCALE

Project Title


AHISEA LOWER SEC. SCHOOL

Sheet Title

SITE PLAN

Sheet Number

**AR-01
07**

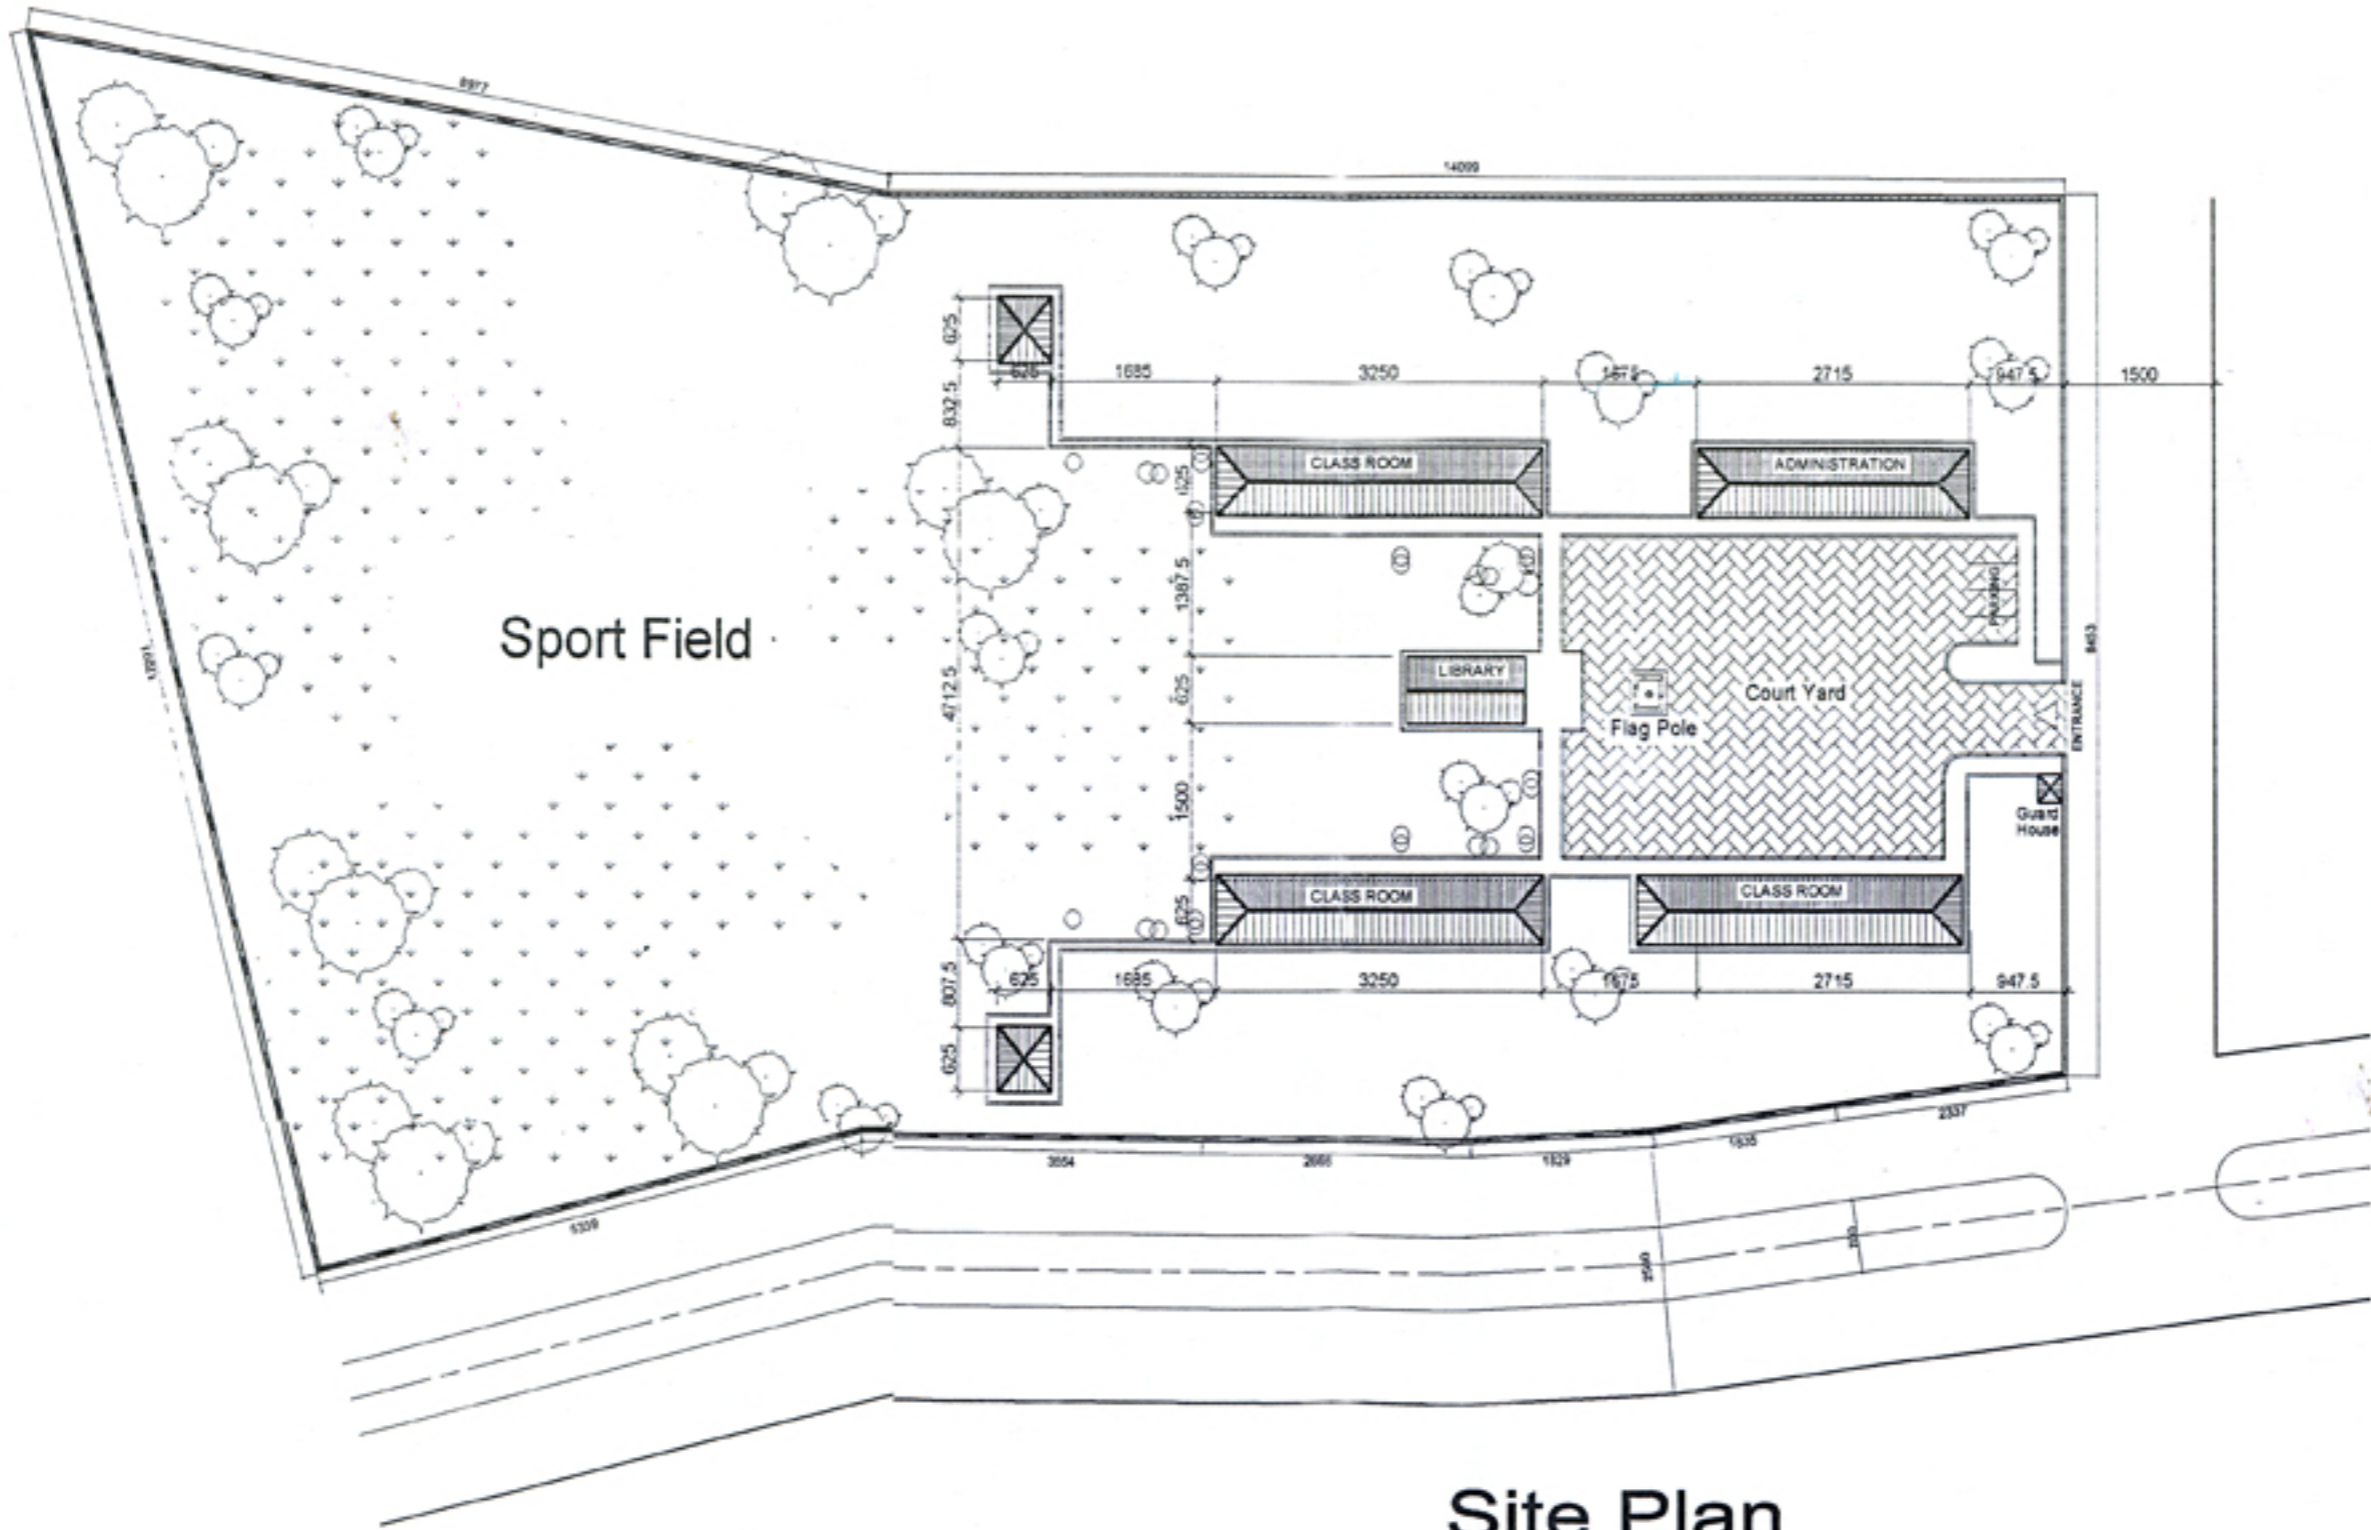

Site Plan